
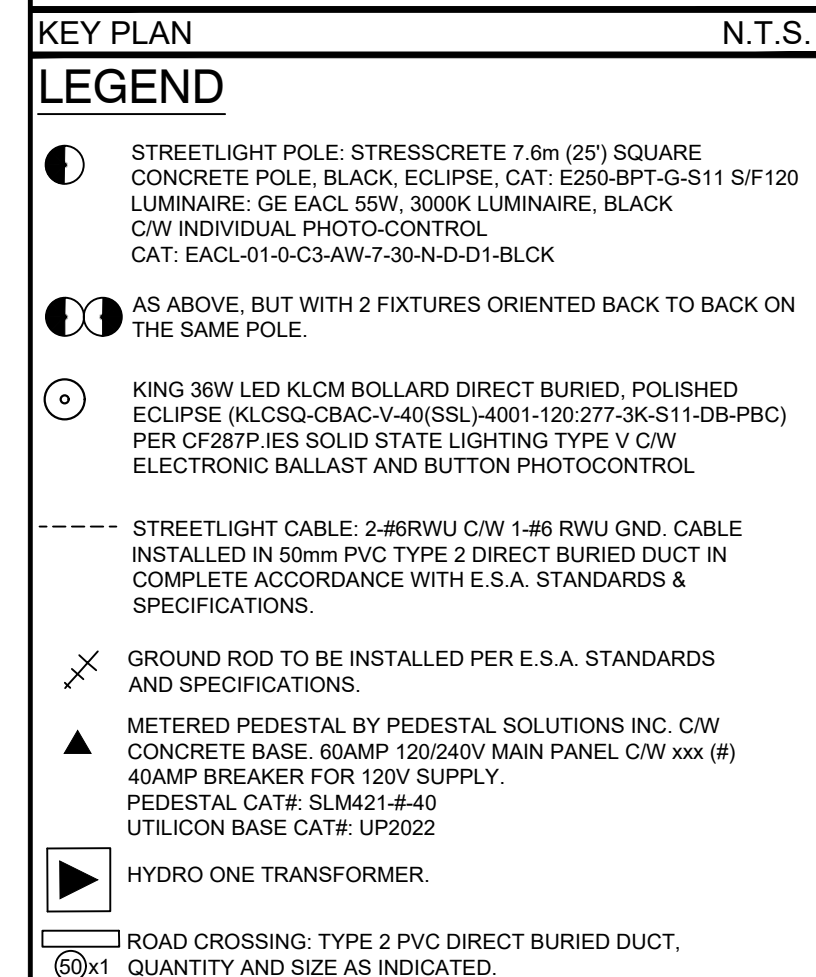


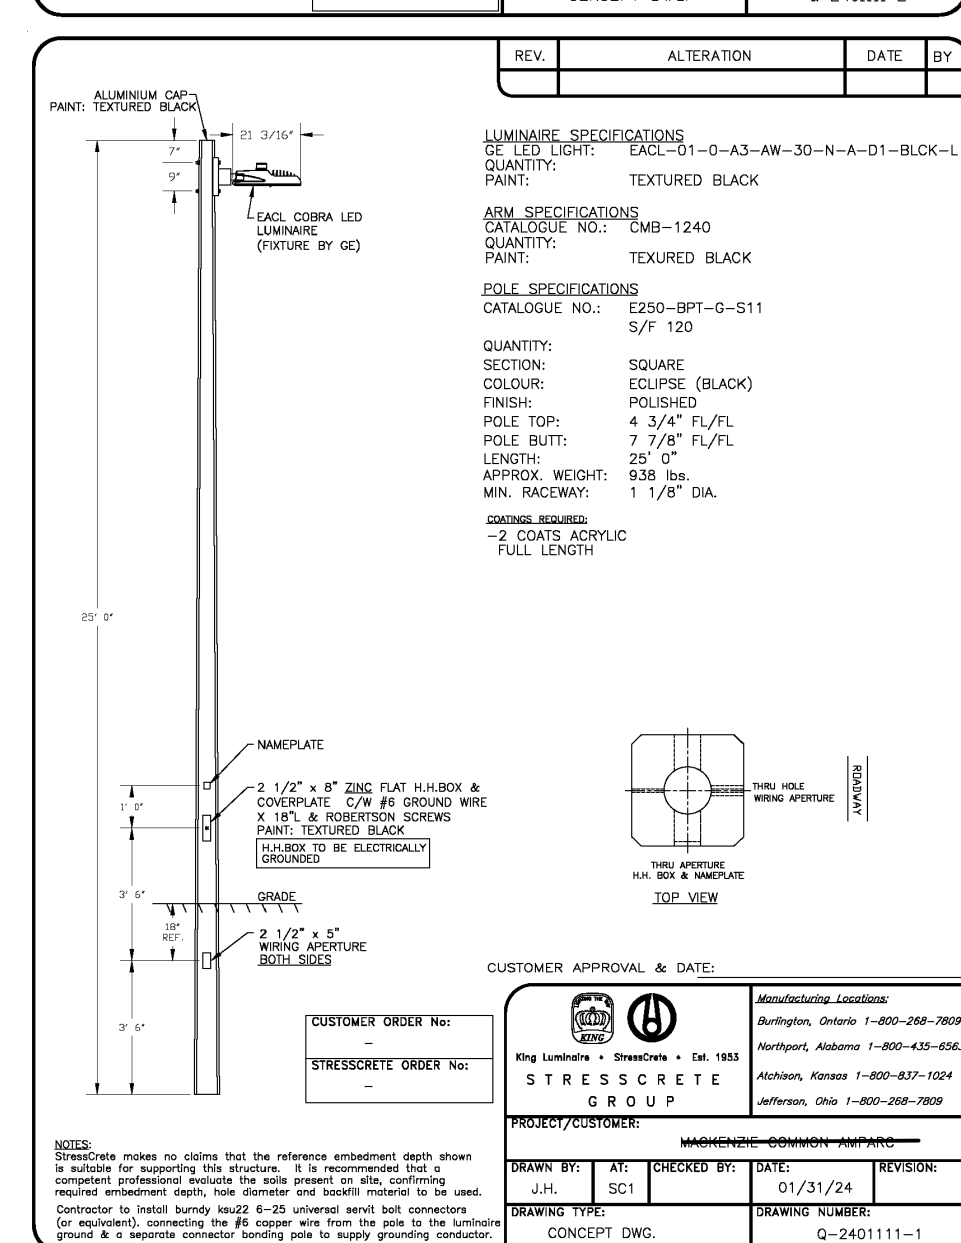

R1	REVISED PER LATEST CIVIL	T.J.G.	2024.04.03	
No.	REVISIONS TO DRAWING	BY	DATE	APPR.

CLIENT	THE ACORN DEVELOPMENT CORPORATION
MUNICIPALITY	 Town of East Gwillimbury
PROJECT TITLE	18490 LESLIE STREET PRIVATE CONDO SITE Residential Subdivision

SHEET TITLE

SITELIGHTING PLAN



RTG SYSTEMS INC.
ELECTRICAL CONSULTING ENGINEERS
3518 Mainway Dr., Suite 201
BURLINGTON ON L7M 1A8
E-MAIL: general@rtgsystems.com

Office: (905) 335-4470
Toronto: (905) 827-7887

			
DESIGNED T.J.G.	DRAWN T.J.G.	CHECKED T.J.G.	
SCALE 1:500		DATE 2021.09.10	
PROJECT NUMBER 05560-00		DWG. NUMBER SL-1	

